


PROGRESSING CAVITY PUMPS CONFERENCE

APRIL 27-29, 2008
 INTERCONTINENTAL HOUSTON
 2222 WEST LOOP SOUTH - HOUSTON, TEXAS

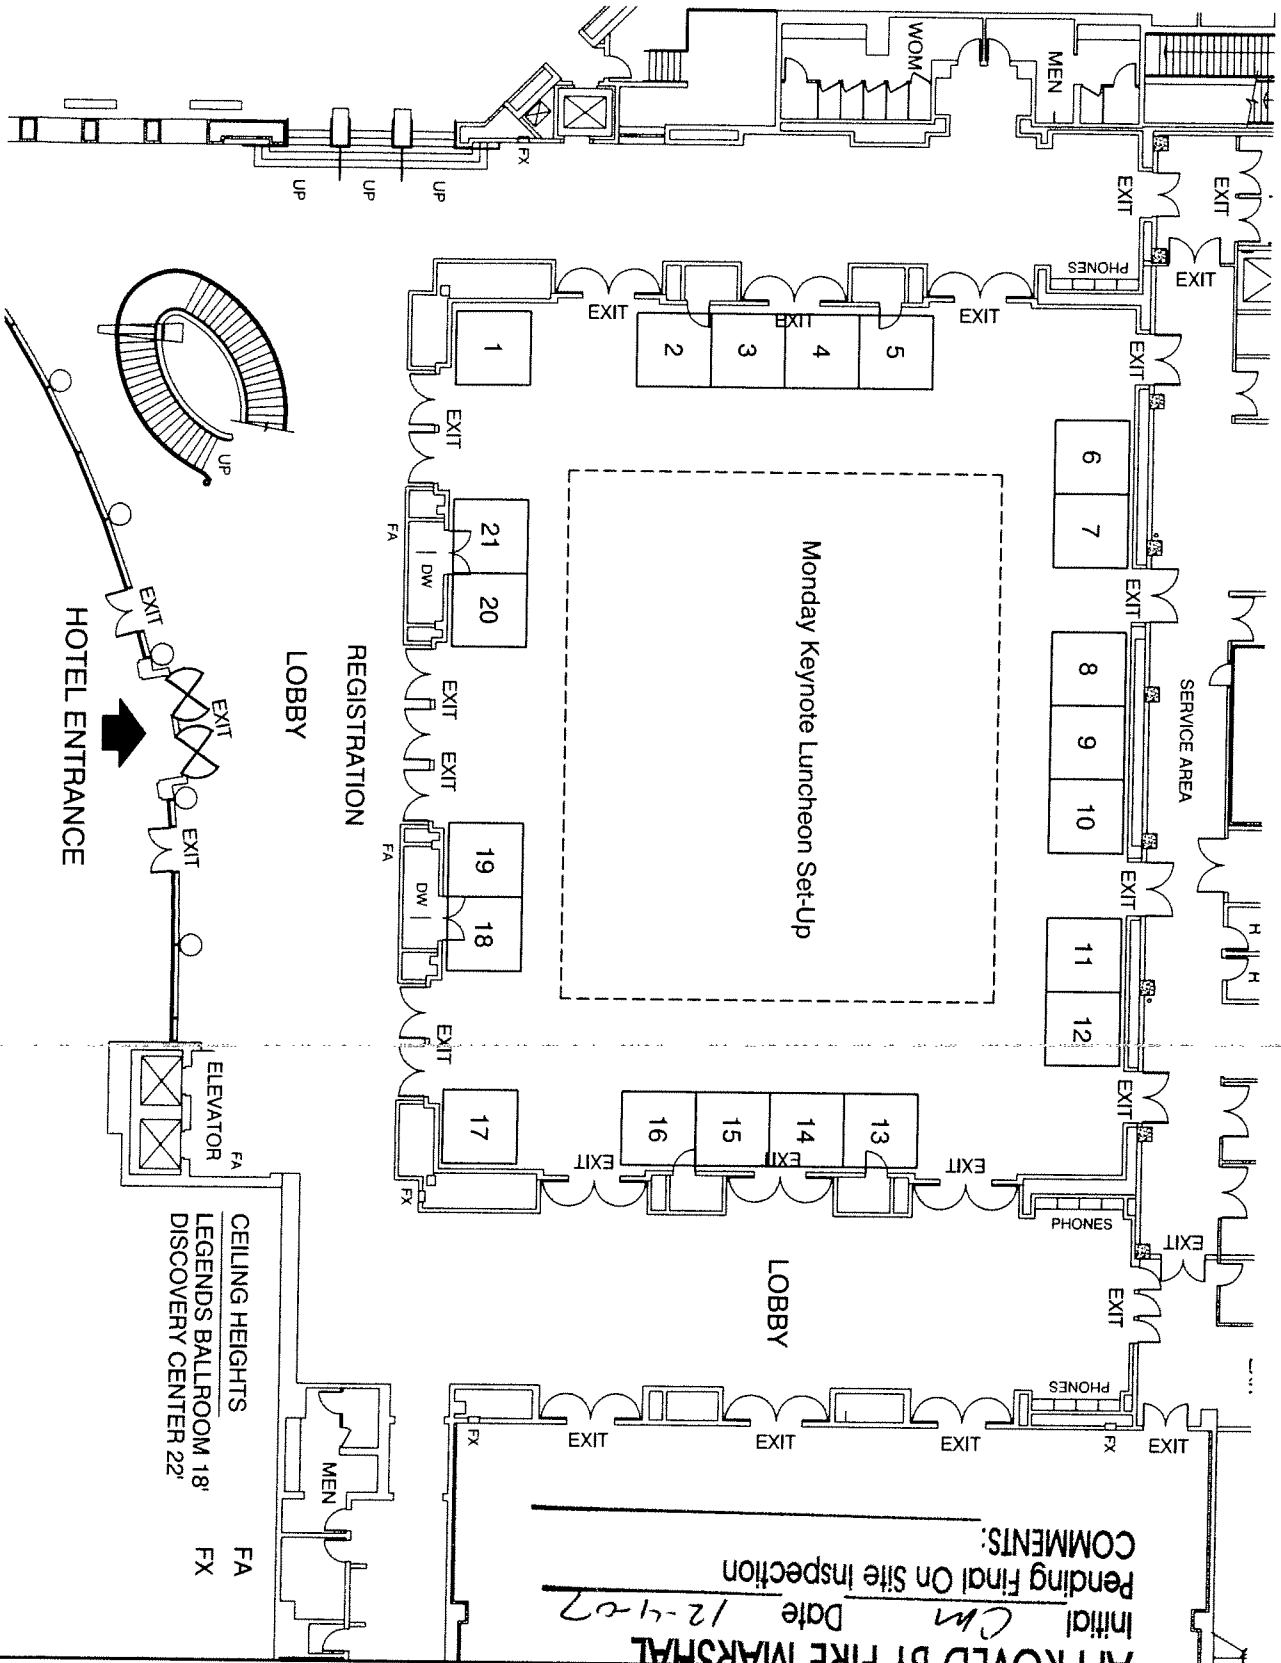

APPROVED BY FIRE MARSHAL
 Initial *CM* Date *12-4-07*
 Pending Final On Site Inspection
 COMMENTS:

REVISION DATE:
12/03/2007

BOOTH COUNT

BLDG. LEGEND:

FREEMAN

DRAWING STARTED:
12/03/07
 FILE PATH:
D:\Show Directory 2008
 DRAWING NAME:
PCPC0048.dwg
 HALL NAME:
INTERCONTINENTAL
 JOB NUMBER:
XXXXXXX
 ACCT. EXEC:
P.HARRIS

NOT TO SCALE

DISCLAIMER

EVERY EFFORT HAS BEEN MADE TO ENSURE THE ACCURACY OF ALL INFORMATION CONTAINED ON THIS FLOOR PLAN. HOWEVER, FREEMAN MAKES NO WARRANTIES, EITHER EXPRESSED OR IMPLIED, AS TO THE LOCATION OF BUILDING UTILITIES OR OTHER ARCHITECTURAL COMPONENTS OF THE FACILITY. A CONSIDERATION OF THE CONSTRUCTION OR USAGE OF AN EXHIBIT, IT IS THE SOLE RESPONSIBILITY OF THE EXHIBITOR TO VERIFY ALL DIMENSIONS AND LOCATIONS. © 2007 FREEMAN CO. ALL RIGHTS RESERVED.

CEILING HEIGHTS
 LEGENDS BALLROOM 18'
 DISCOVERY CENTER 22'

FA FX

HOTEL ENTRANCE

Monday Keynote Luncheon Set-Up

LOBBY

REGISTRATION

LOBBY

SERVICE AREA

ELEVATOR

MEN

PHONES

PHONES

